

LEGEND:

- PROPOSED MINOR CONTOURS
- - - PROPOSED MAJOR CONTOURS
- EXISTING MINOR CONTOURS
- - - EXISTING MAJOR CONTOURS
- LIMITS OF DISTURBANCE
- UNDERGROUND ELECTRIC
- OVERHEAD ELECTRIC
- DRAINAGE LAYER COLLECTION PIPE


NOTE: WASTE WHICH IS ENCOUNTERED OUTSIDE OF LEACHATE CUTOFF CURTAINS #1 AND #3 SHALL BE RELOCATED TO THE AREA INSIDE OF THE CURTAINS SO THAT IT WILL BE CAPPED.

SEE SHEET C-06 FOR SECTIONS "A-A" AND "B-B"

TRIAD ENGINEERING, INC.
 200 AVIATION DRIVE
 WINCHESTER, VA 22602
 PH: 540.667.9300 FAX: 540.667.2260


NO.	DATE	DESCRIPTION
1	05-21-2010	REVISED PER WSCP COMMENTS
2	05-31-2011	REVISED PER WSCP COMMENTS
3	06-28-2011	REVISED PER WSCP COMMENTS

CADD FILE:	C-06.DWG
DRAWN BY:	JCG
CHECKED BY:	DDD
DATE:	05-21-2010
SCALE:	1" = 40'

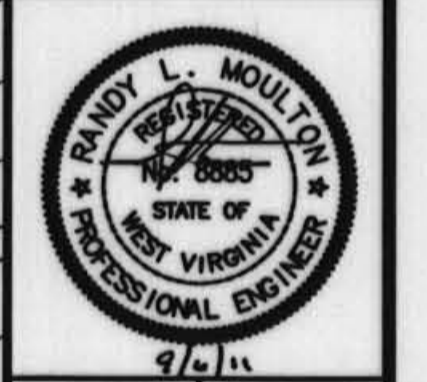

**CAPON SPRINGS LANDFILL
 FINAL CLOSURE PROJECT
 HAMPSHIRE COUNTY, WEST VIRGINIA**

FINAL GRADING PLAN

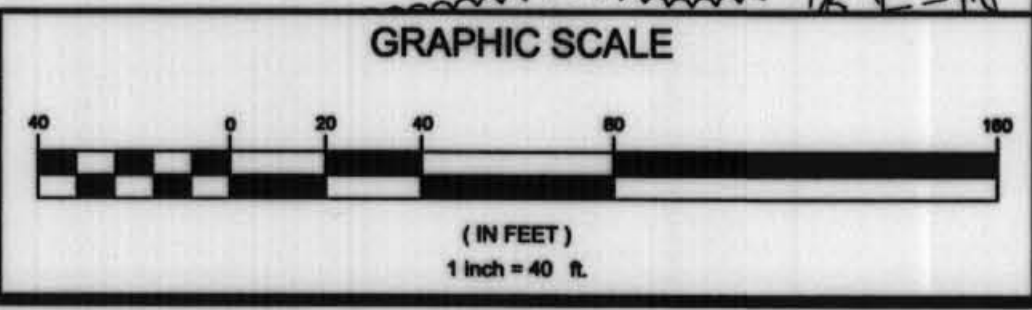

TRIAD
 TRIAD ENGINEERING, INC.
 www.triadeng.com

SHEET NUMBER:
C-05

JOB NO.: 07-08-0283